


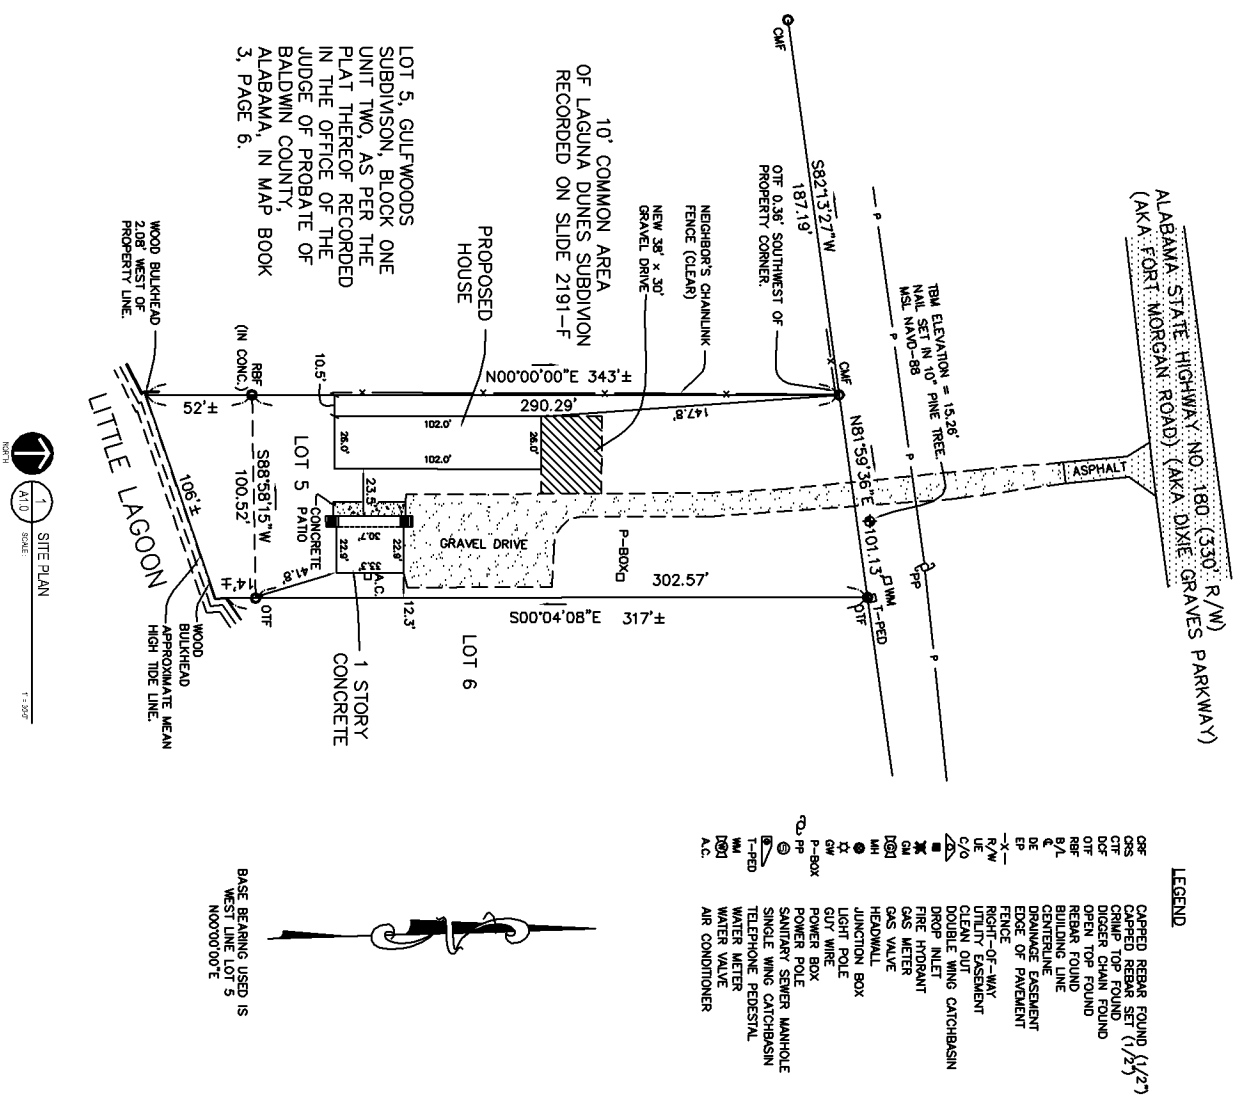





A north arrow pointing upwards and a circle divided horizontally with '1' in the top half and 'A2.1' in the bottom half.



A2.2.2

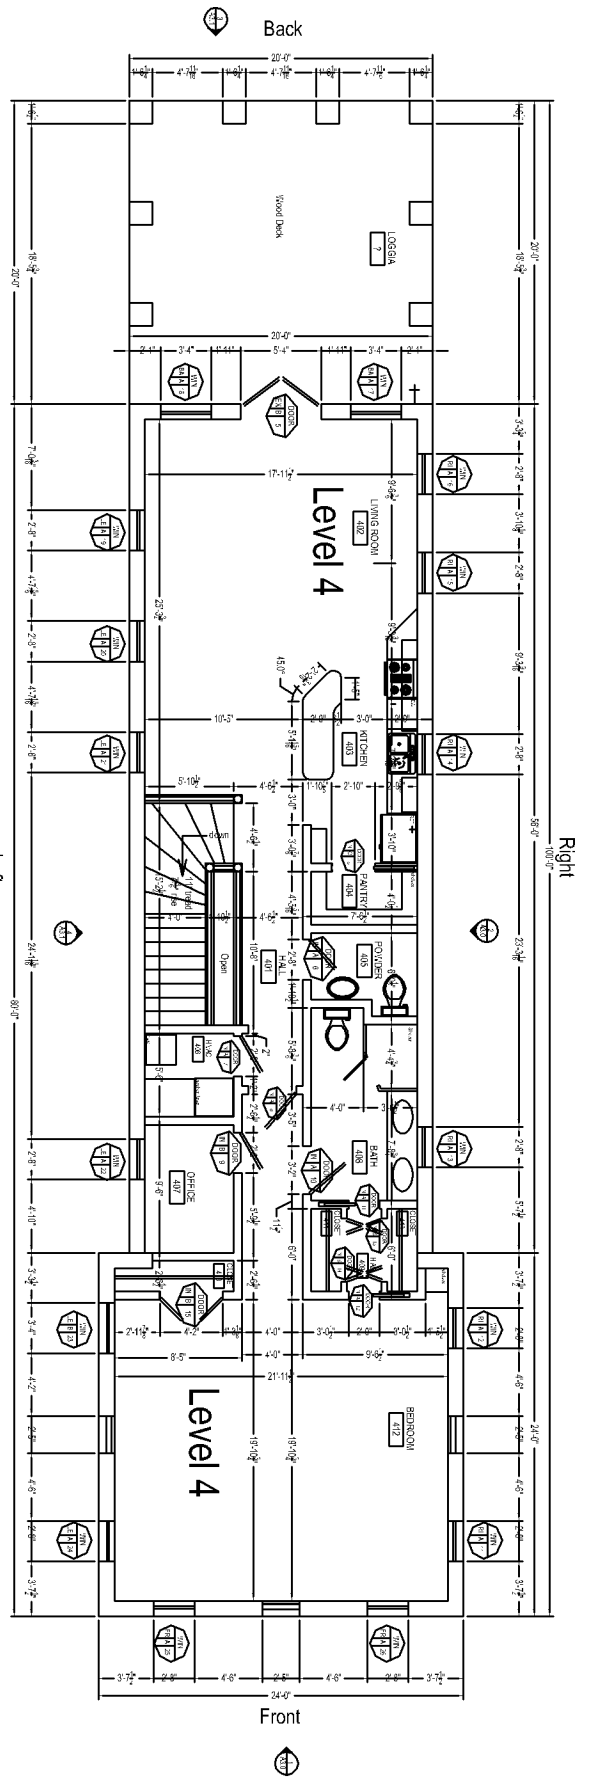


1
FLOOR PLAN - LEVEL 4
SCALE: 1/8" = 1'-0"

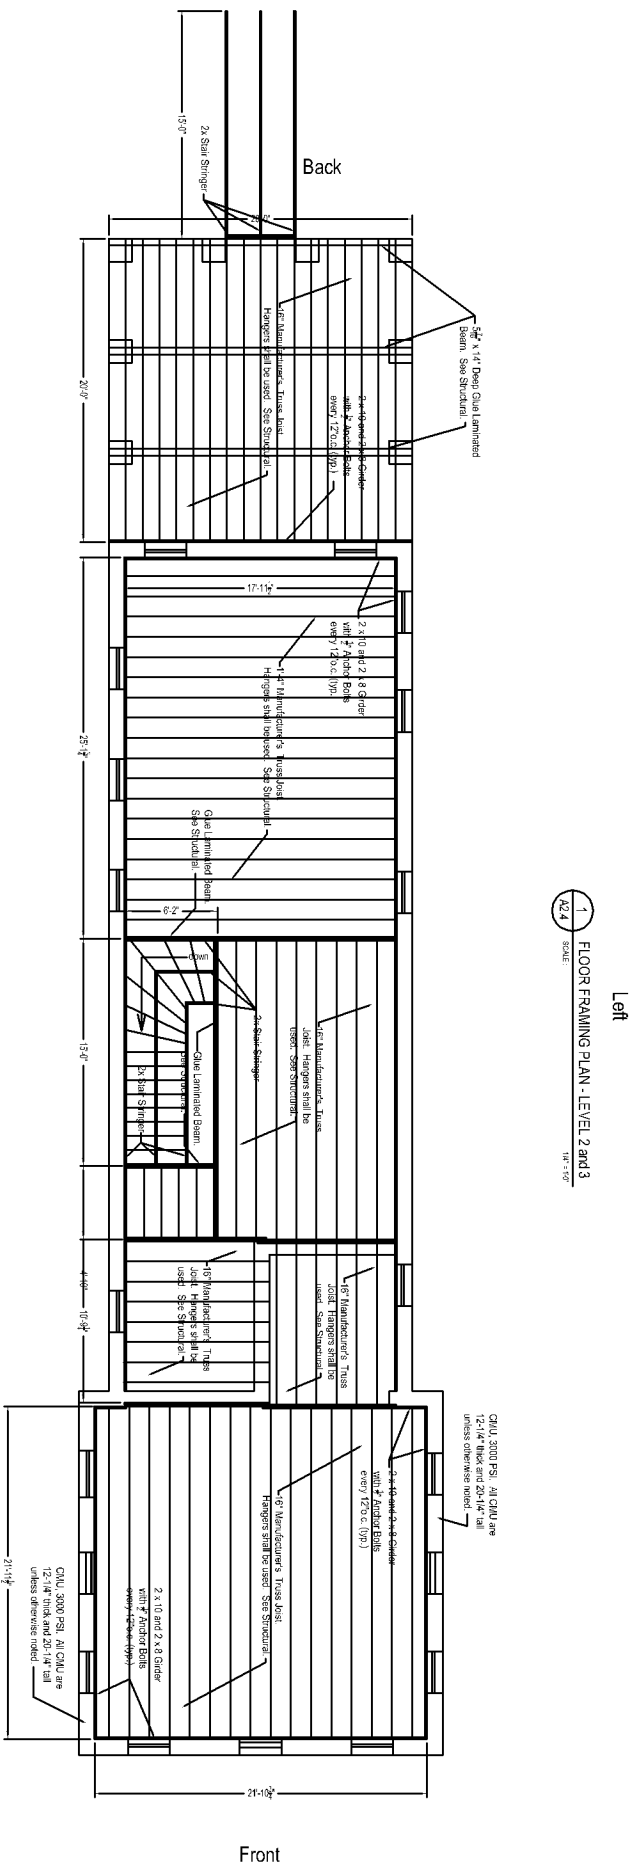

Back


Back

2 ROOF PLAN
A2.5 SCALE
Left
1/4" = 1'-0"

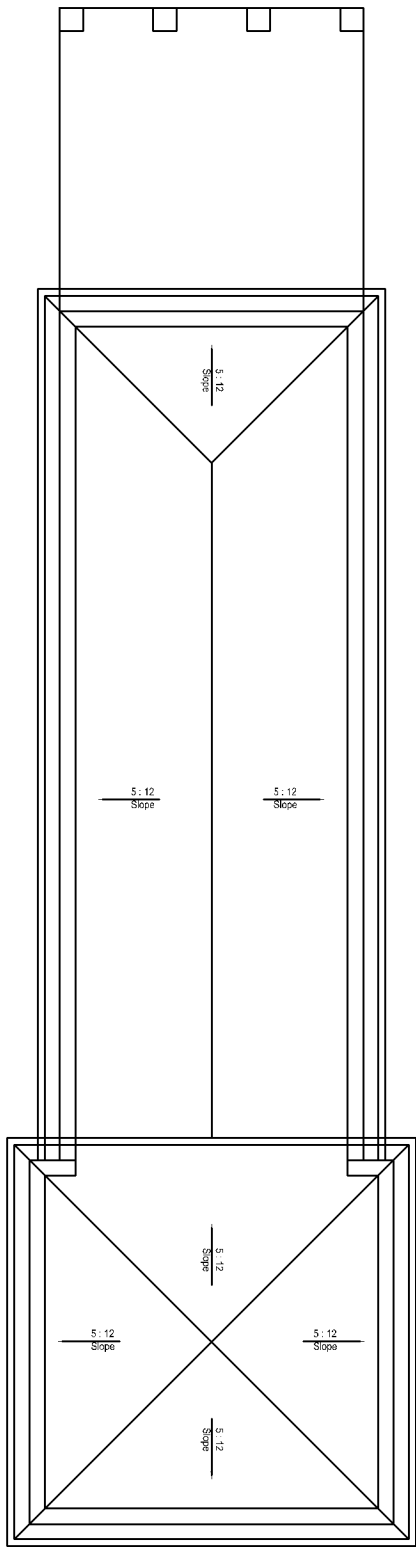


Front


1 TRUSS FRAMING PLAN
A2.5 SCALE
Left
1/4" = 1'-0"

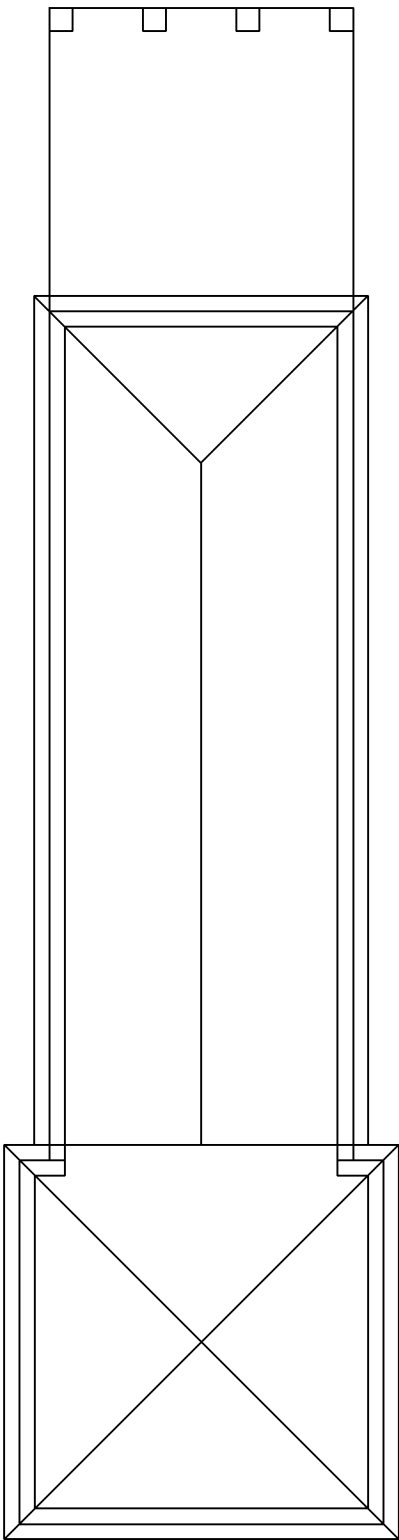


Front

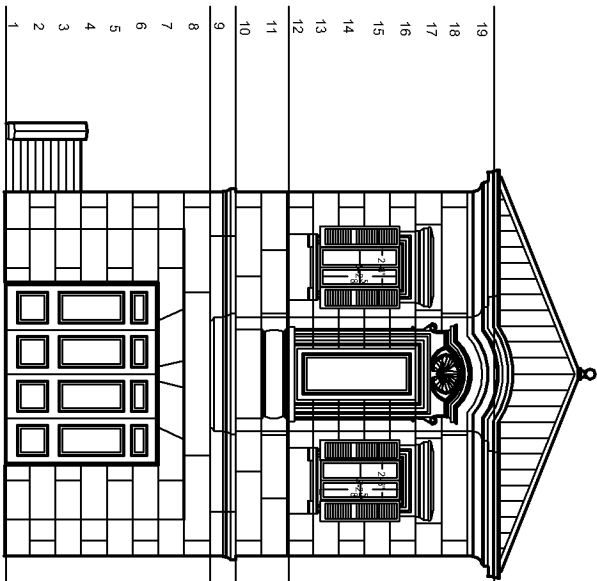


1 EXTERIOR ELEVATION -
SCALE: 1/8" = 1'-0"

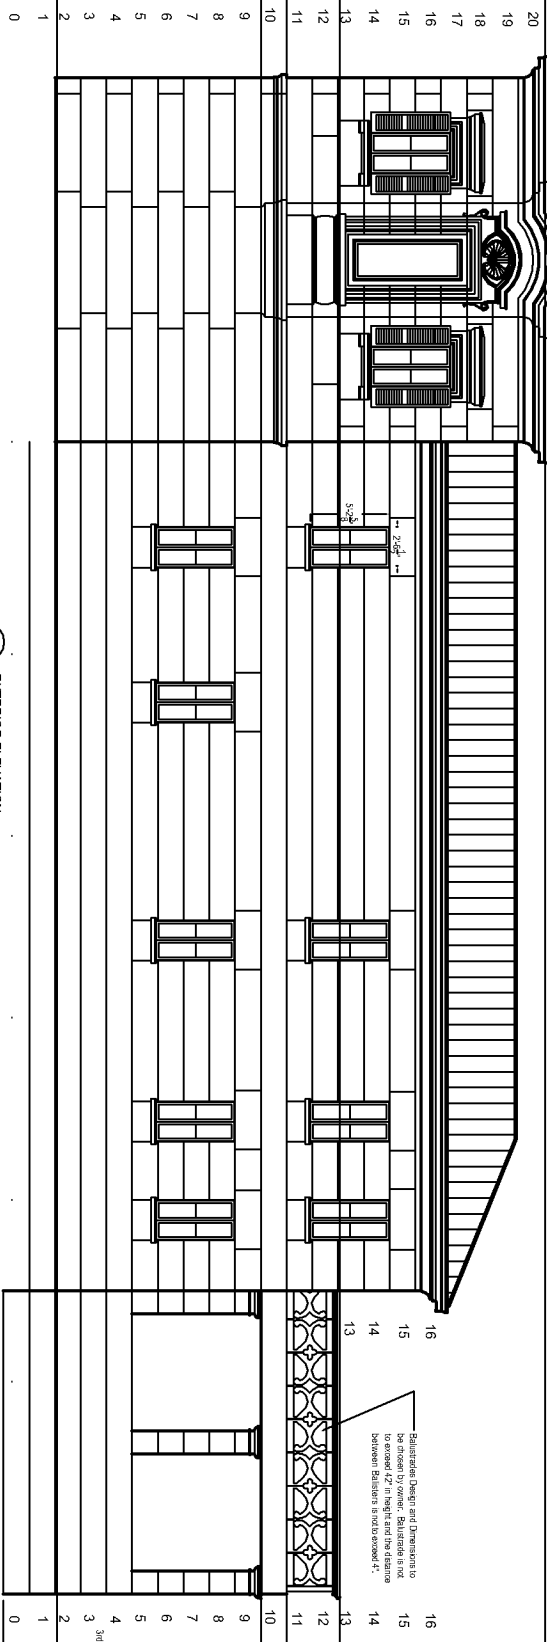



2 EXTERIOR ELEVATION -
SCALE: 1/8" = 1'-0"

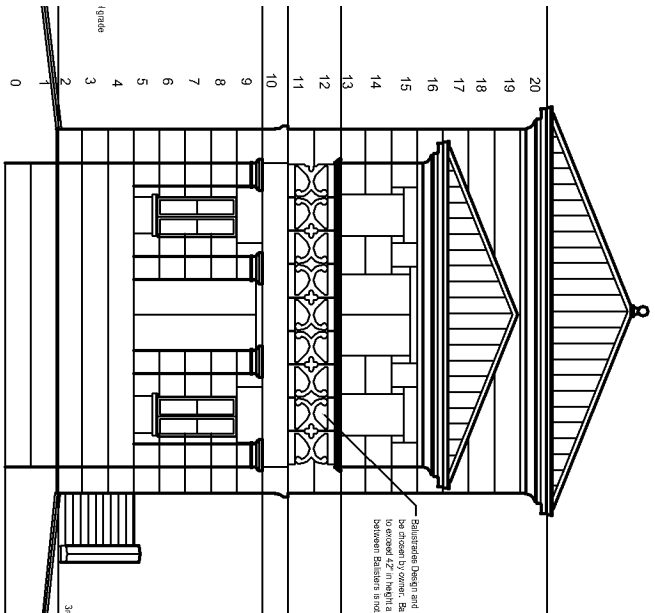

3 SECTION @ FRONT ENTRY STAIRCASE
A3.1 SCALE: 1/8" = 1'-0"

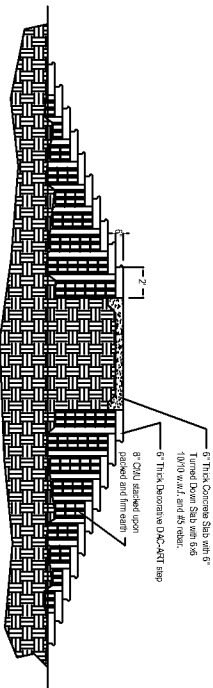

4 SECTION @ FRONT ENTRY STAIRCASE
A3.1 SCALE: 1/8" = 1'-0"

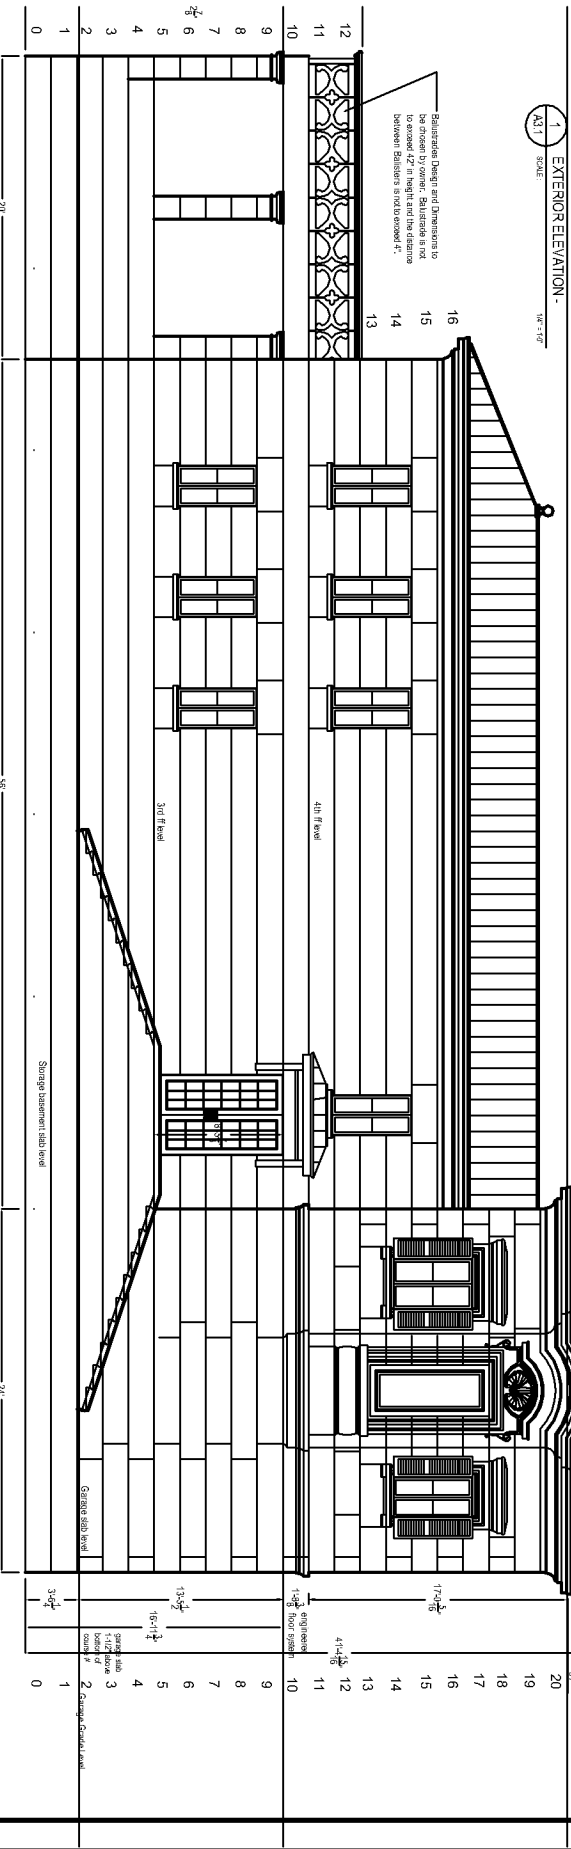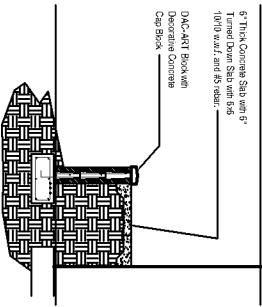


2 EXTERIOR ELEVATION -
A3.1 SCALE: 1/8" = 1'-0"


A3.1

The Wilder Residence

Architectural Design: Théodore Dial
Plans by: Dial Construction, Inc.
Phone: 251 476 4001 PO Box 6130 Mobile AL 36660
Phone: 251 973 0673 www.dial-institute.com


25 April 2007

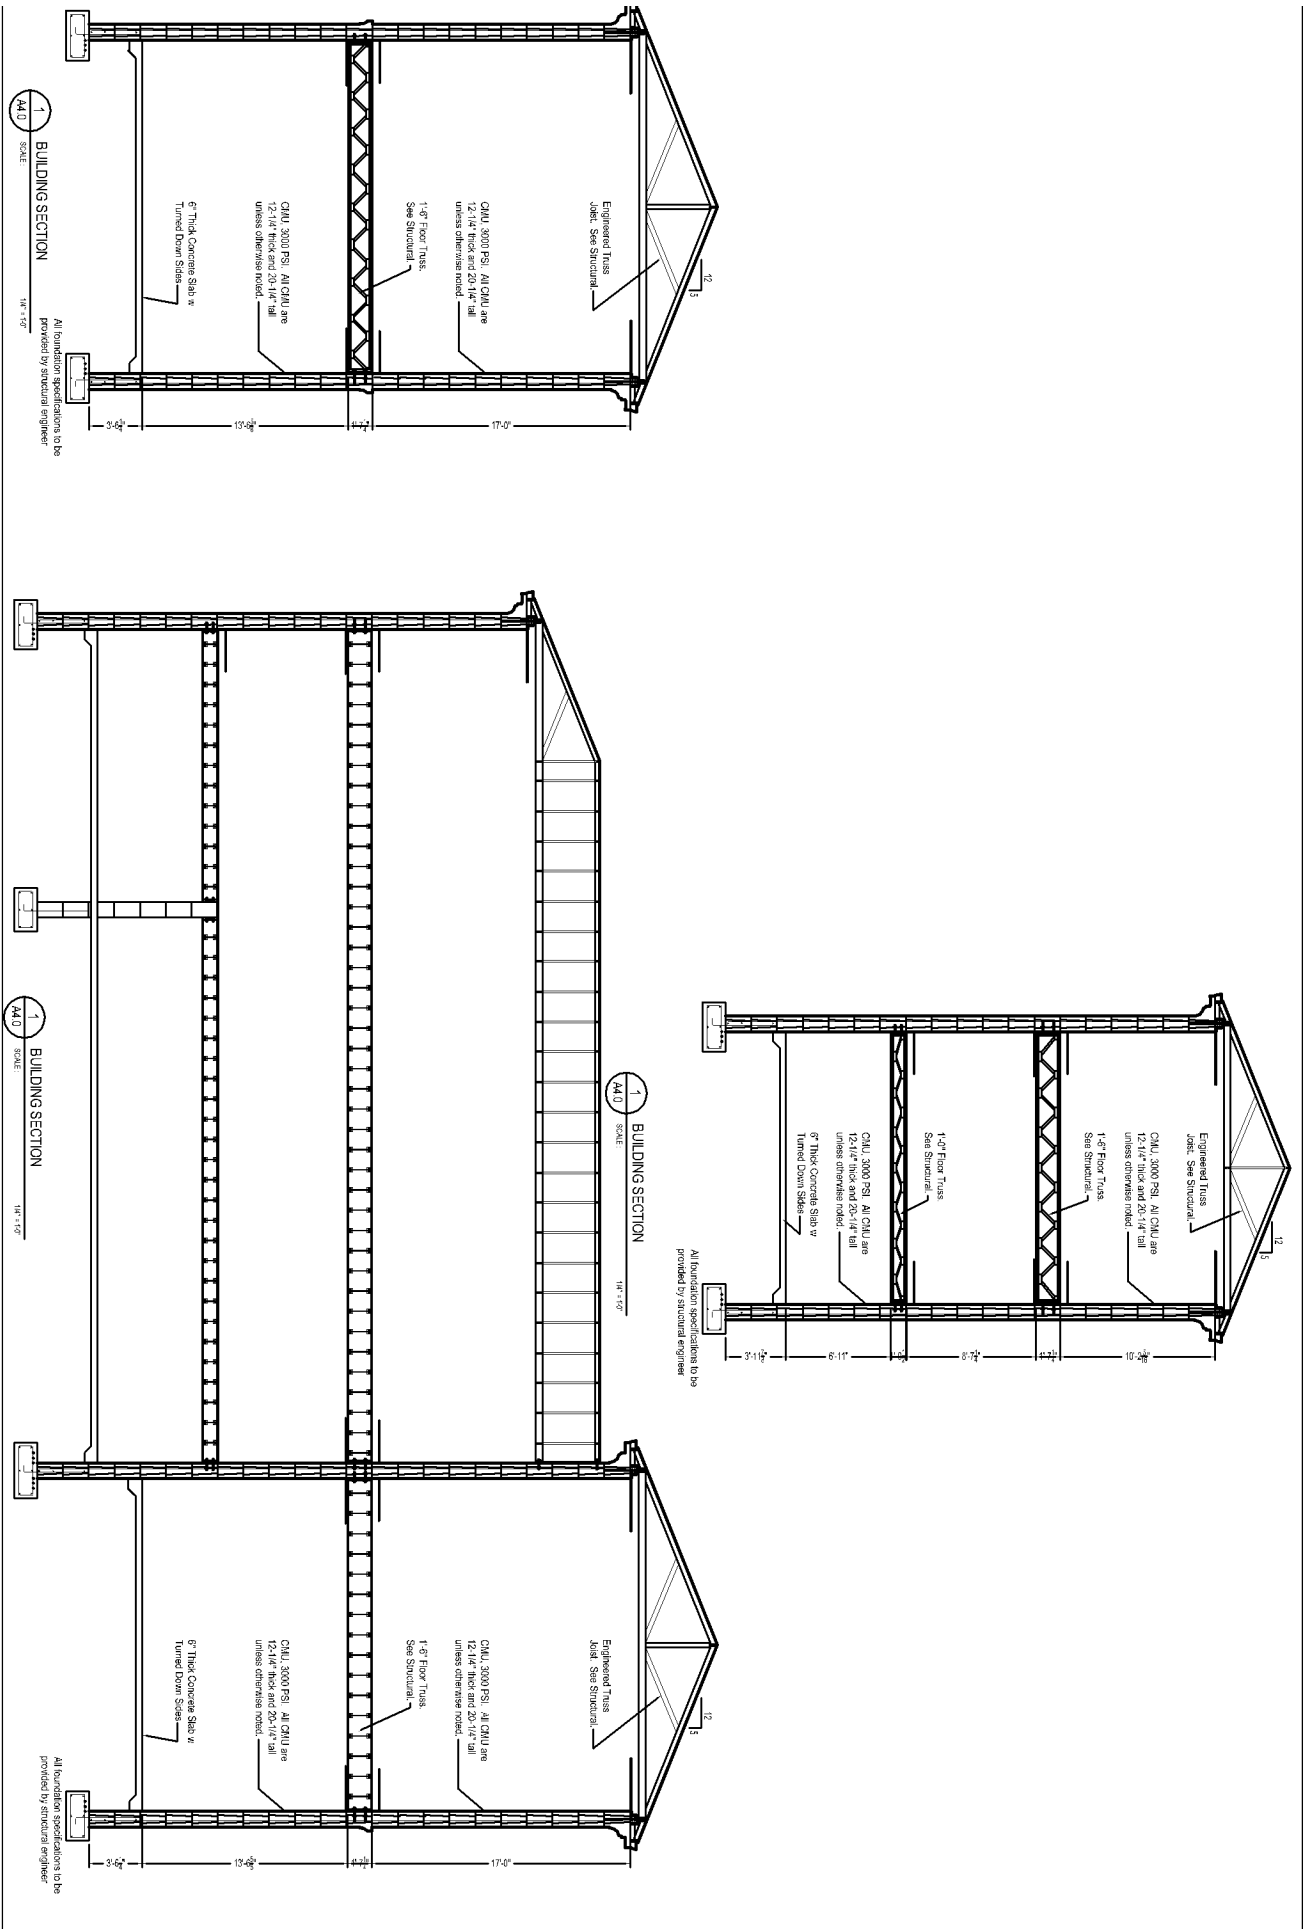

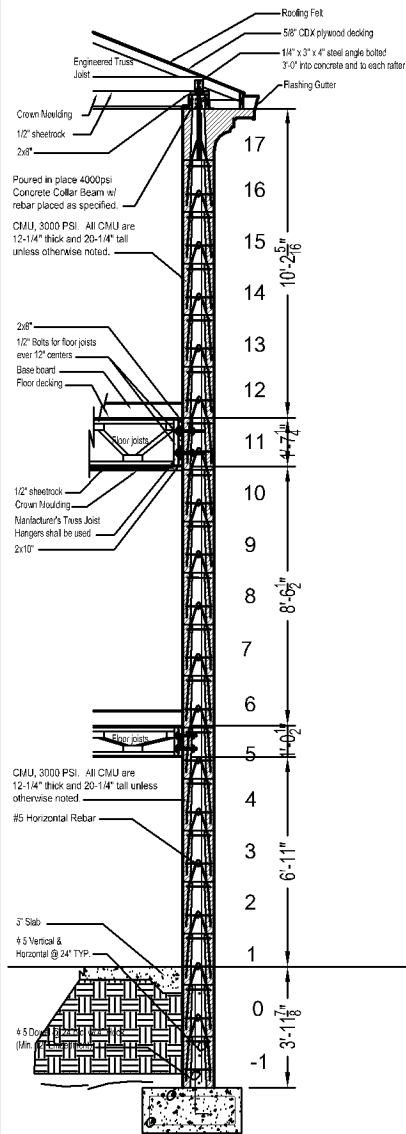


All foundation specifications to be provided by structural engineer

1 WALL SECTION
SCALE: 1/2" = 1'-0"

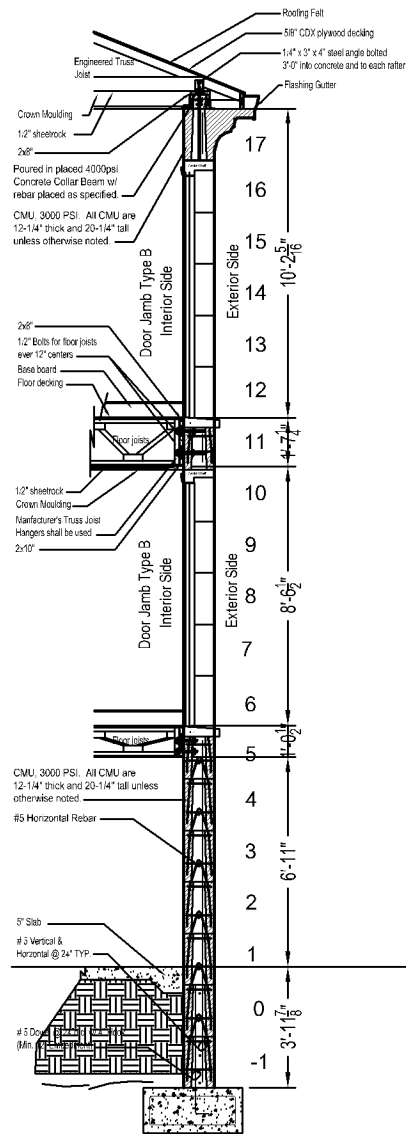


All foundation specifications to be provided by structural engineer

2 WALL SECTION
SCALE: 1/2" = 1'-0"

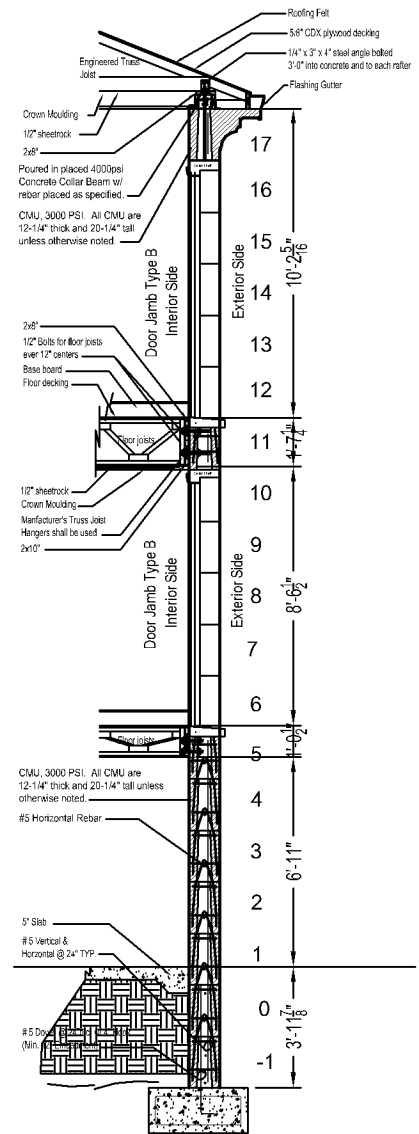


All foundation specifications to be provided by structural engineer



3 WALL SECTION
SCALE: 1/2" = 1'-0"

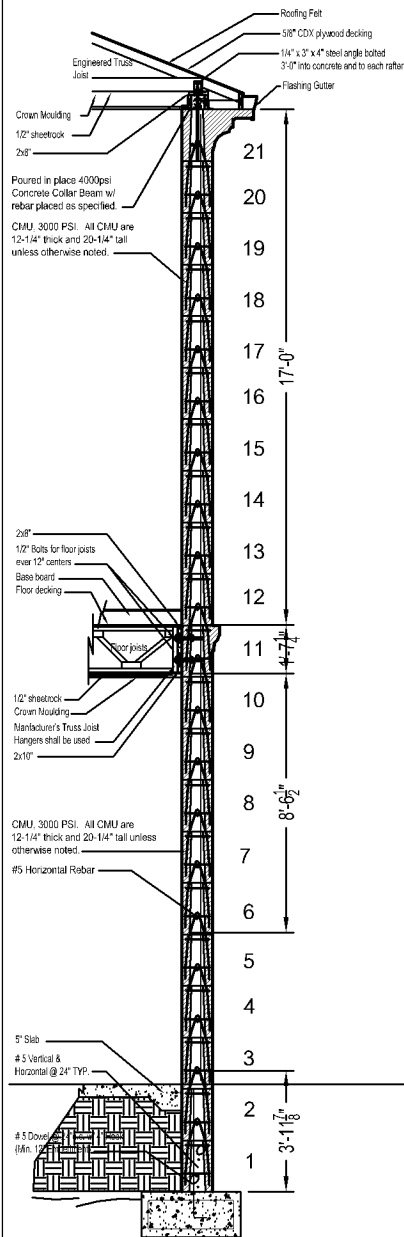

4 WALL SECTION
SCALE: 1/2" = 1'-0"

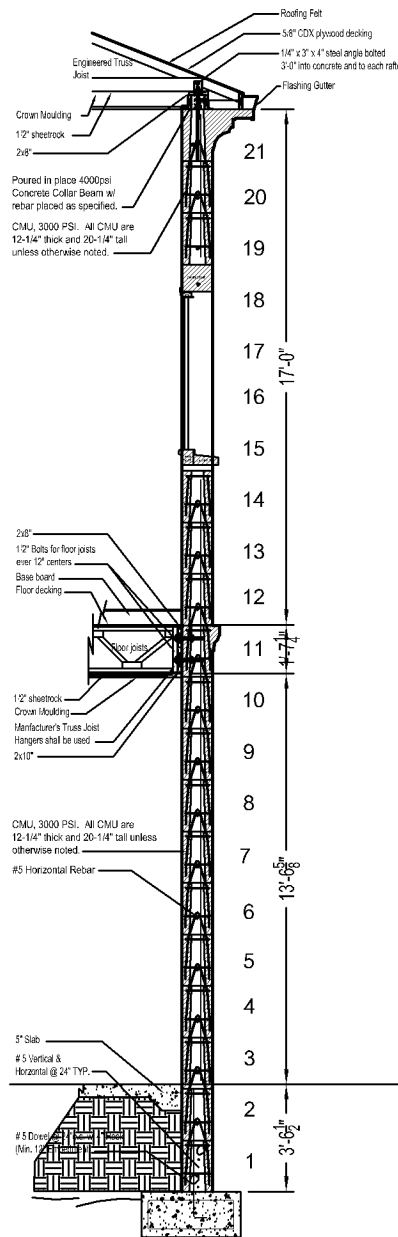


5 WALL SECTION
SCALE: 1/2" = 1'-0"

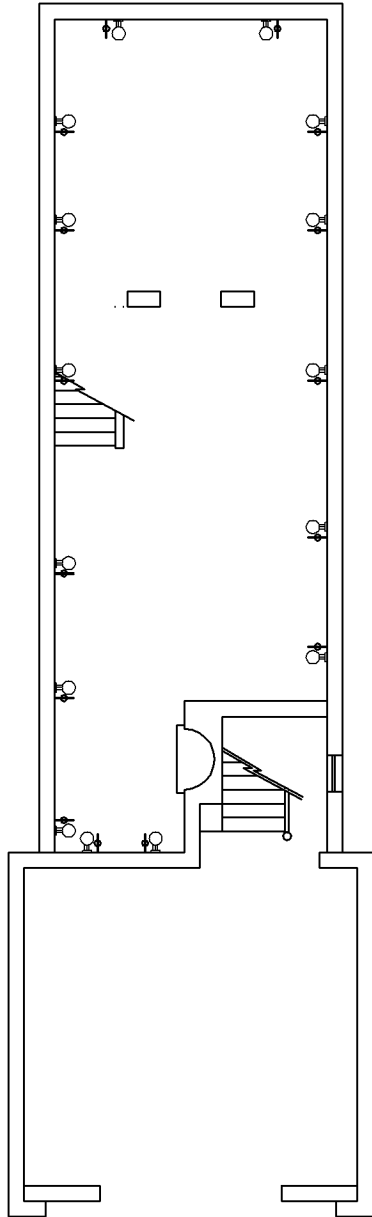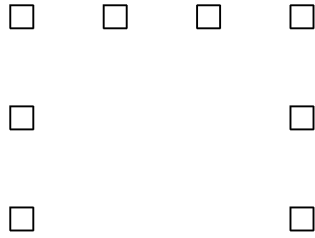


1
E1.0
SCALE: 1/8" = 1'-0"

ELECTRICAL POWER PLAN - LEVEL 1 and 2

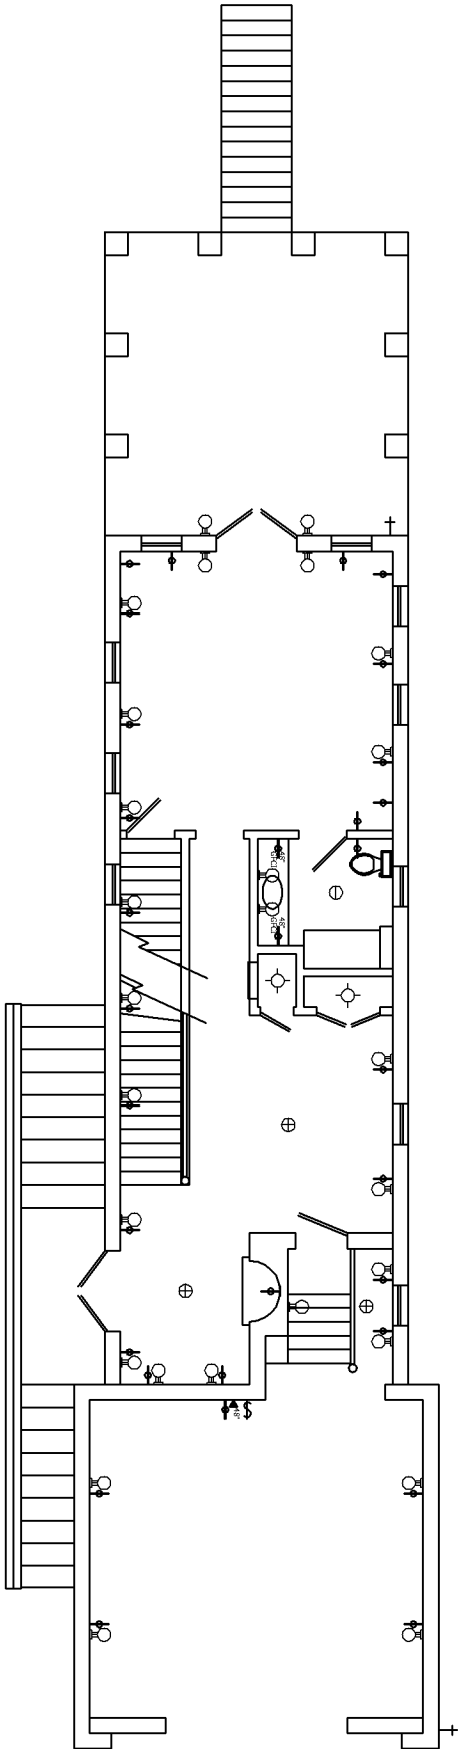

1
E1.0
SCALE: 1/8" = 1'-0"


ELECTRICAL POWER PLAN - LEVEL 1 and 2

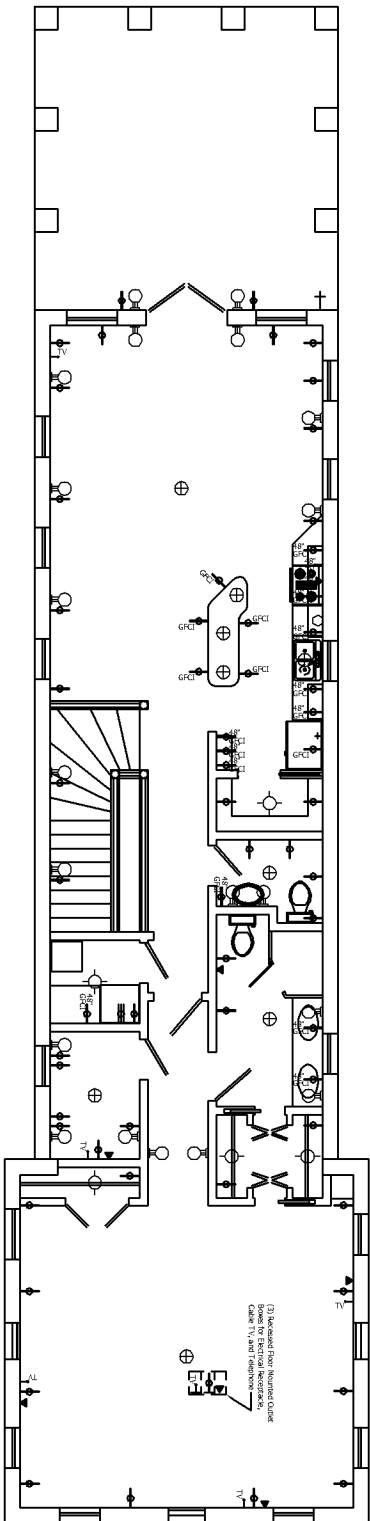


4
E1.1 ELECTRICAL POWER PLAN - LEVEL 4
SCALE 1/8" = 1'-0"

[illegible]

 
Scale 2/30 = 1




Scale 1 = 1

 

1000

 

Section 7 -

 

SCALE: 1" = 1'

FOUNDATION PLAN

SCALE: 3/16" = 1'

REVISIONS	
DATE	DESCRIPTION

ANIL BADVE & ASSOCIATES
DESIGN, PLANNING, CONSULTING
CONSTRUCTION MANAGEMENT
1300 N. MCKENZIE ST.
P. O. BOX 554
FOLEY, ALABAMA 36536
TEL./FAX: (205) 943-5662/941-2344
E-MAIL: anilbadve@hotmail.com

FOUNDATION PLAN
WILDER RESIDENCE
GULF SHORES, ALABAMA

ISSUED BY:	AB
ISSUED TO:	AVIL, B.
ISSUED IN:	
DATE:	AS 24-2004
DATE:	MAY 2007
DATE FILED:	
FILED IN:	LIBRARY
FILED NO:	